



UNIT 4 & 5

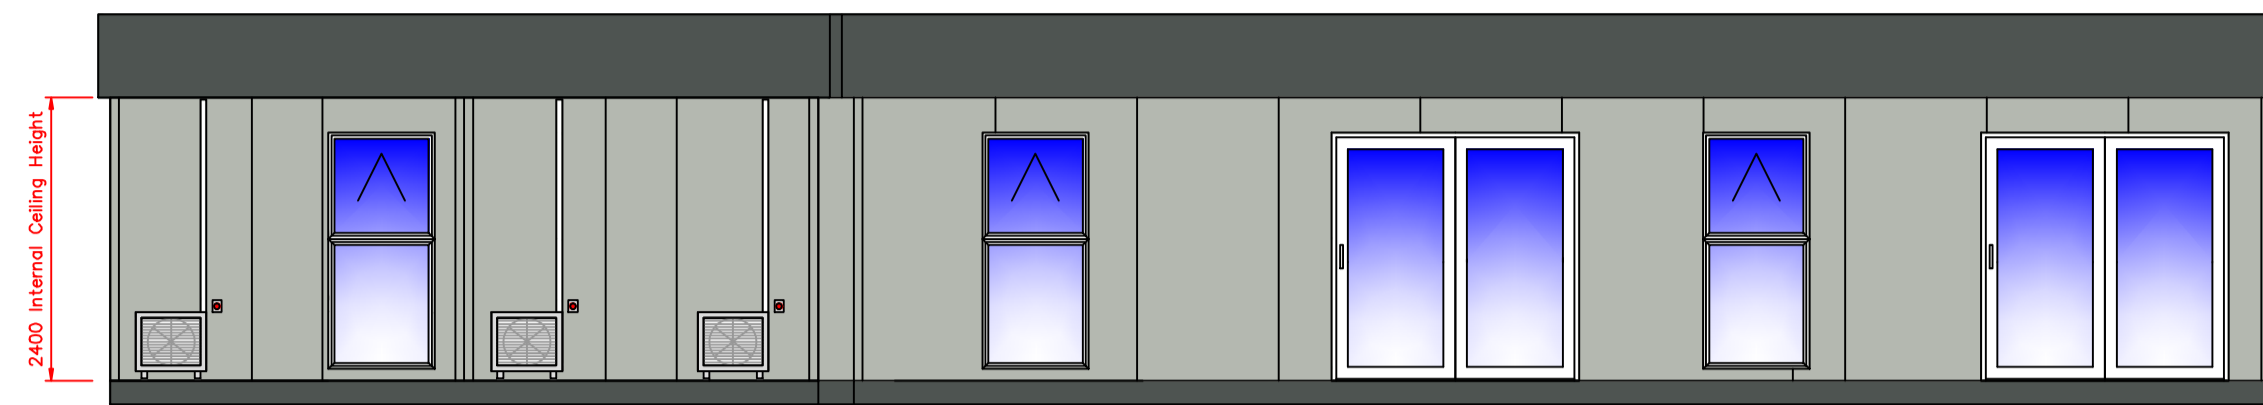


ELEVATION A

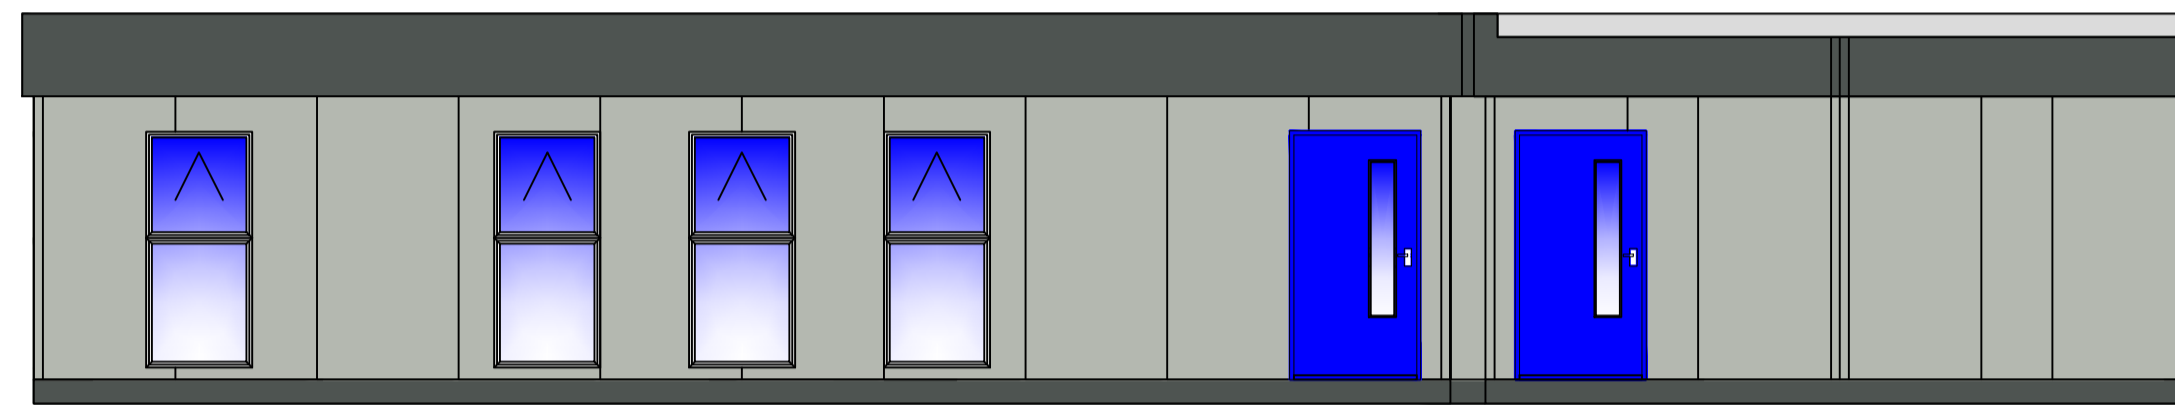


ELEVATION C



ELEVATION B

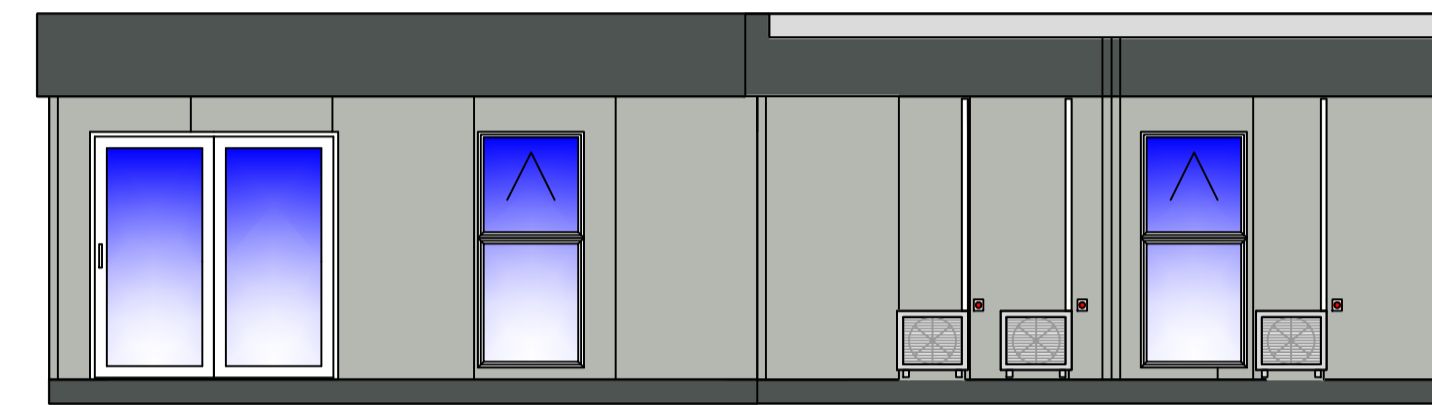

ELEVATION D

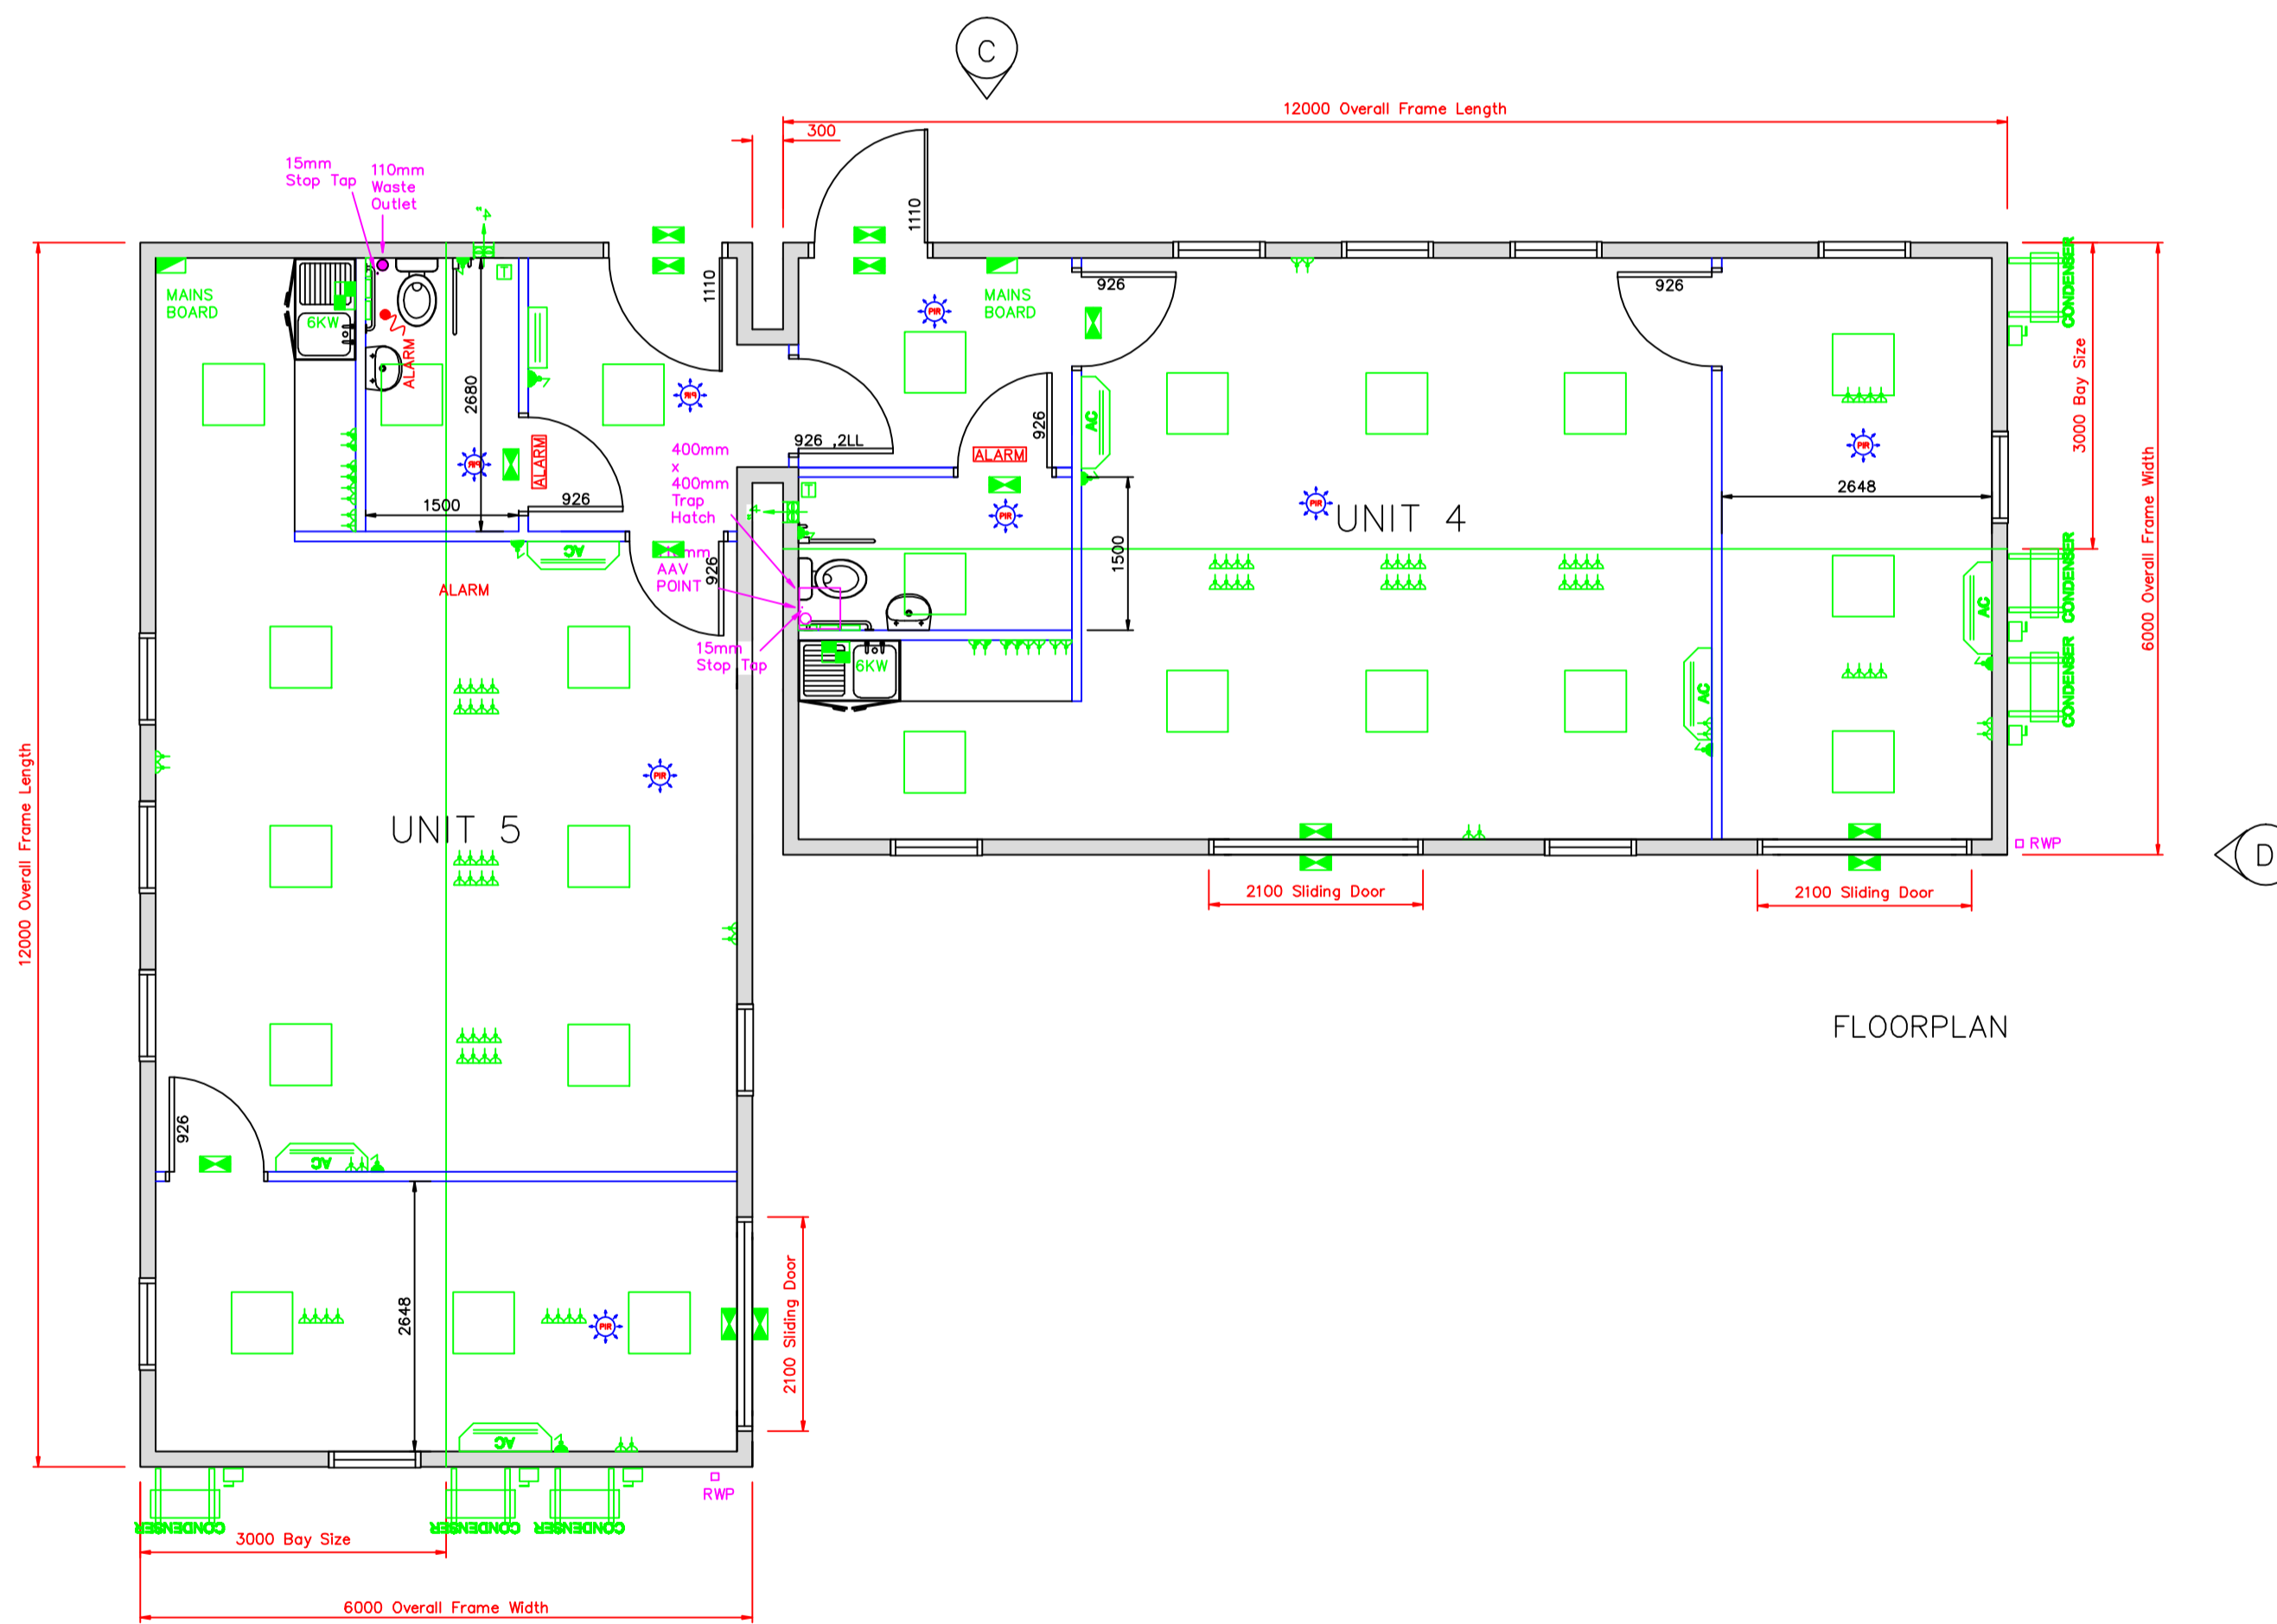

FLOORPLAN

FLOORPLAN

ELECTRICAL LEGEND

	DISTRIBUTION BOARD
	SUB - CONSUMER UNIT
	ISOLATOR
	DOUBLE SWITCHED SOCKET FITTED @ 450mm AFFL
	DOUBLE SWITCHED SOCKET FITTED @ 1100mm AFFL
	SINGLE SWITCHED SOCKET FITTED @ 450mm AFFL
	SINGLE SWITCHED SOCKET FITTED @ 1100mm AFFL
	SWITCHED SPUR
	NON-SWITCHED SPUR
	DATA OUTLET
	TELEPHONE OUTLET
	FLUORESCENT LIGHT - (SIZE STATED)
	FLUORESCENT LIGHT - C/W DIFFUSER
	EMERGENCY VERSION OF ABOVE
	FLUORESCENT LIGHT - VAPOUR PROOF
	FLUORESCENT LIGHT - CATEGORY 2
	BATTEN LIGHT FITTING
	EMERGENCY LUMINAIRE TO B.S. 5266 PT 1 1000
	C/W EXTT / RUNNING MAN SIGNS TO B.S. 5408 PT 1 1000
	EMERGENCY LUMINAIRE C/W PIR
	INTERNAL BULKHEAD LIGHT
	EXTERNAL BULKHEAD LIGHT
	SWITCH FITTED @ 1000mm AFFL
	KEY SWITCH
	PULL CORD
	CONVECTOR HEATER
	HIGH LEVEL FAN HEATER
	TUBULAR FROST HEATER (SIZE STATED)
	FROSTWATCHER HEATER (SIZE STATED)
	THERMOSTAT
	OVERSINK WATER HEATER
	UNDERSINK WATER HEATER
	CEILING MOUNTED EXTRACTOR
	WALL MOUNTED EXTRACTOR FAN

FIRE ALARM KEY

	HEAT DETECTOR
	SMOKE DETECTOR
	SOUNDER
	MANUAL CALL POINT
	FIRE ALARM PANEL

REV	DATE	DESCRIPTION	BY

TITLE
PROPOSED LAYOUT & ELEVATIONS

CLIENT: SUSSEX COUNTY CRICKET CLUB
 SCALE: 1:125 @ A3
 DRAWN BY: G.R. DATE: 01-10-15
 PROJECT NO: 15/16718-01
 CAD FILE: UNIT 4&5 REVD